

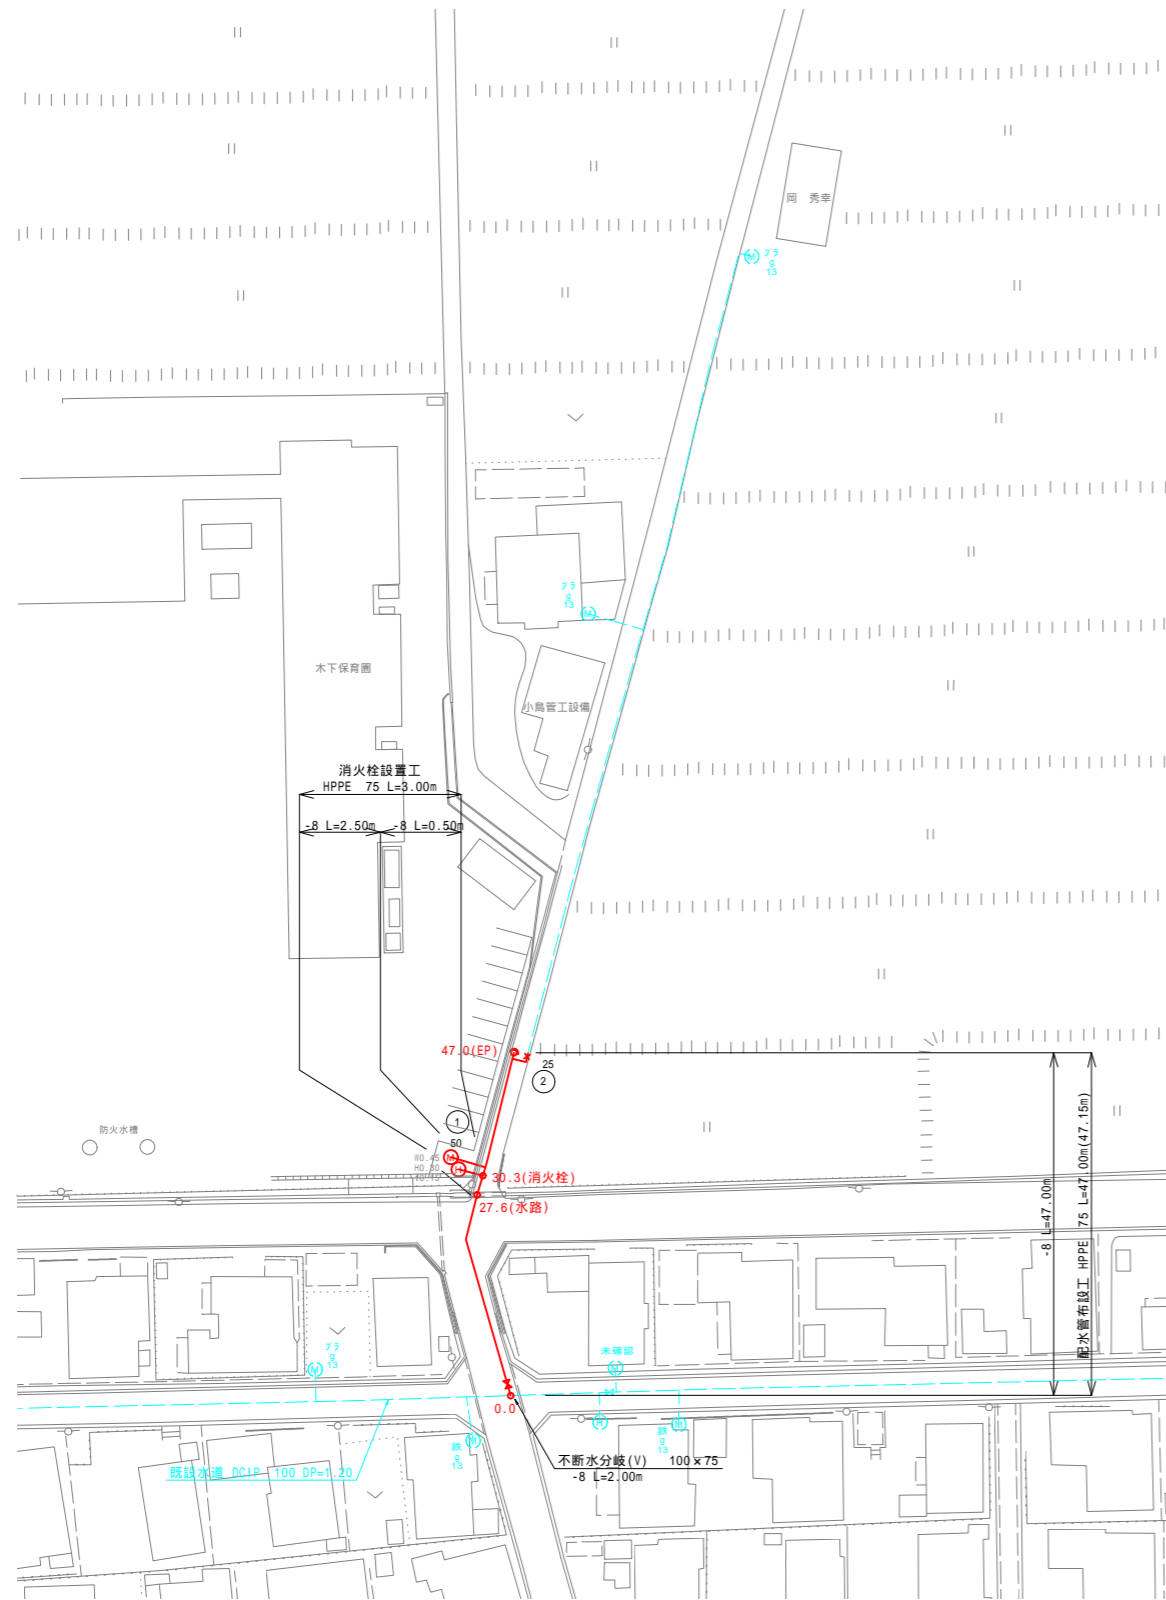


平面図 縮尺 1:500

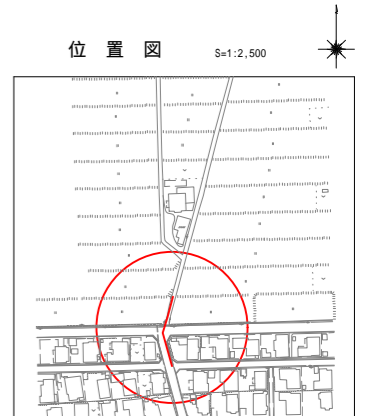



横断面図 縮尺 1:100

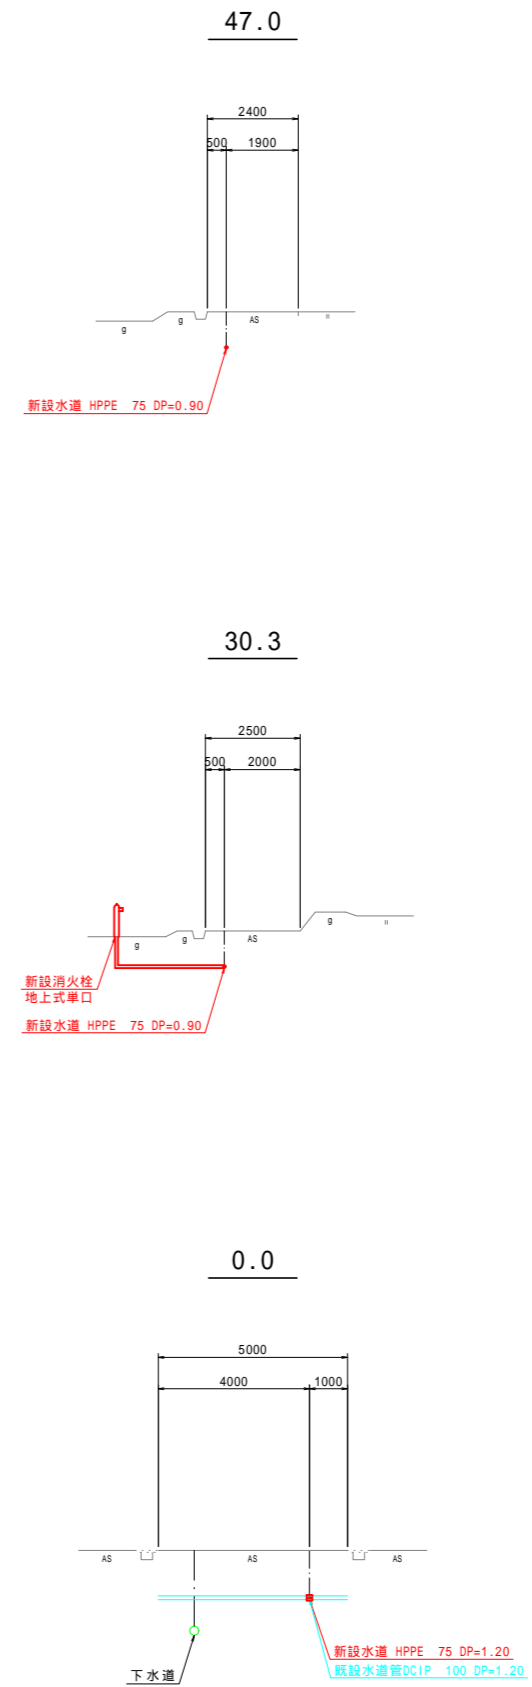

令和2年度 木下保育園遊設関連上水道管布設工事			
平面図・横断面図		縮尺 図示	
箕輪町 木下 北城			
町長		課長	
監査	設計	監製	
図面番号 4 葉中之 1			
箕輪町役場			

# 配管詳細図

縮尺 Free

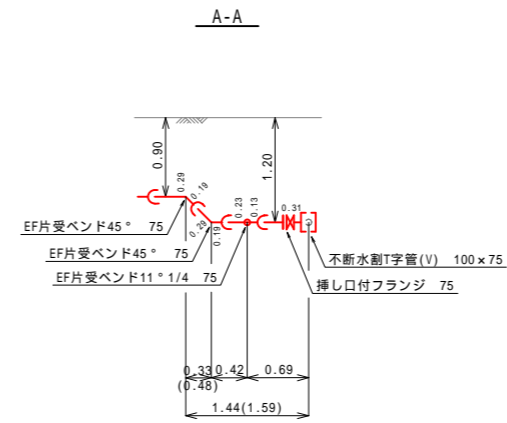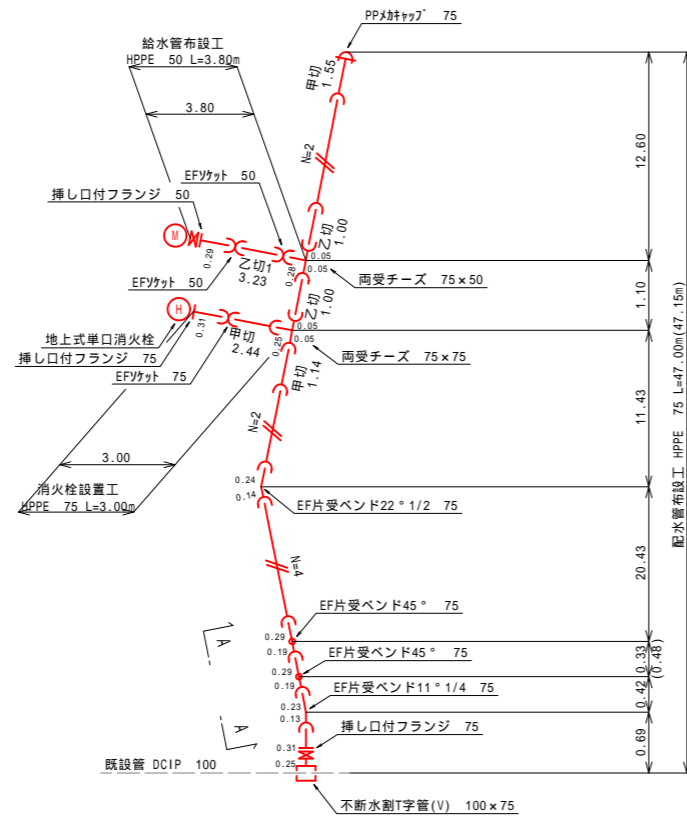


令和2年度 木下保良斎造設開運上水道管布設工事	
配管詳細図	縮尺 図示
箕輪町 木下 北城	
町長	課長
原 直	計 策
図面番号 4 葉中之 2	
箕輪町役場	




# 配水管標準掘削断面図

S=1:20

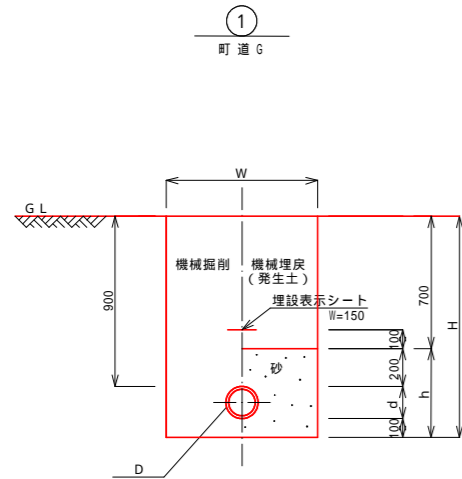

番号	D	d	h	H	W
- 1	DCIP 200	220	520	1,220	600
- 2	DCIP 150	170	470	1,170	550
- 3	DCIP 100	120	420	1,120	550
- 4	DCIP 75	90	390	1,090	550
- 5	HI-PE 200	220	520	1,220	550
- 6	HI-PE 150	170	470	1,170	550
- 7	HI-PE 100	110	410	1,110	550
- 8	HI-PE 75	90	390	1,090	550
- 9	HI-PE 50	60	360	1,060	550

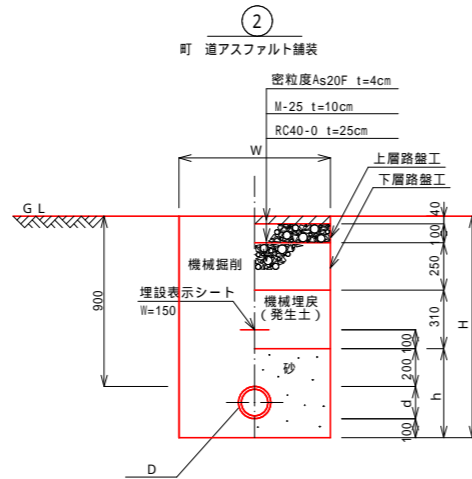

番号	D	d	h	H	W
- 1	DCIP 200	220	520	1,220	600
- 2	DCIP 150	170	470	1,170	550
- 3	DCIP 100	120	420	1,120	550
- 4	DCIP 75	90	390	1,090	550
- 5	HI-PE 200	220	520	1,220	550
- 6	HI-PE 150	170	470	1,170	550
- 7	HI-PE 100	110	410	1,110	550
- 8	HI-PE 75	90	390	1,090	550
- 9	HI-PE 50	60	360	1,060	550

